


NO.	ISSUE	DATE

<b>PROJECT NO.:</b>	1820028
<b>DATE:</b>	6/JUNE/22
<b>SCALE:</b>	AS NOTED
<b>DRAWN BY:</b>	JRS/BBM
<b>CHECKED BY:</b>	

<b>DRAWING NUMBER</b>	AB-6
-----------------------	------

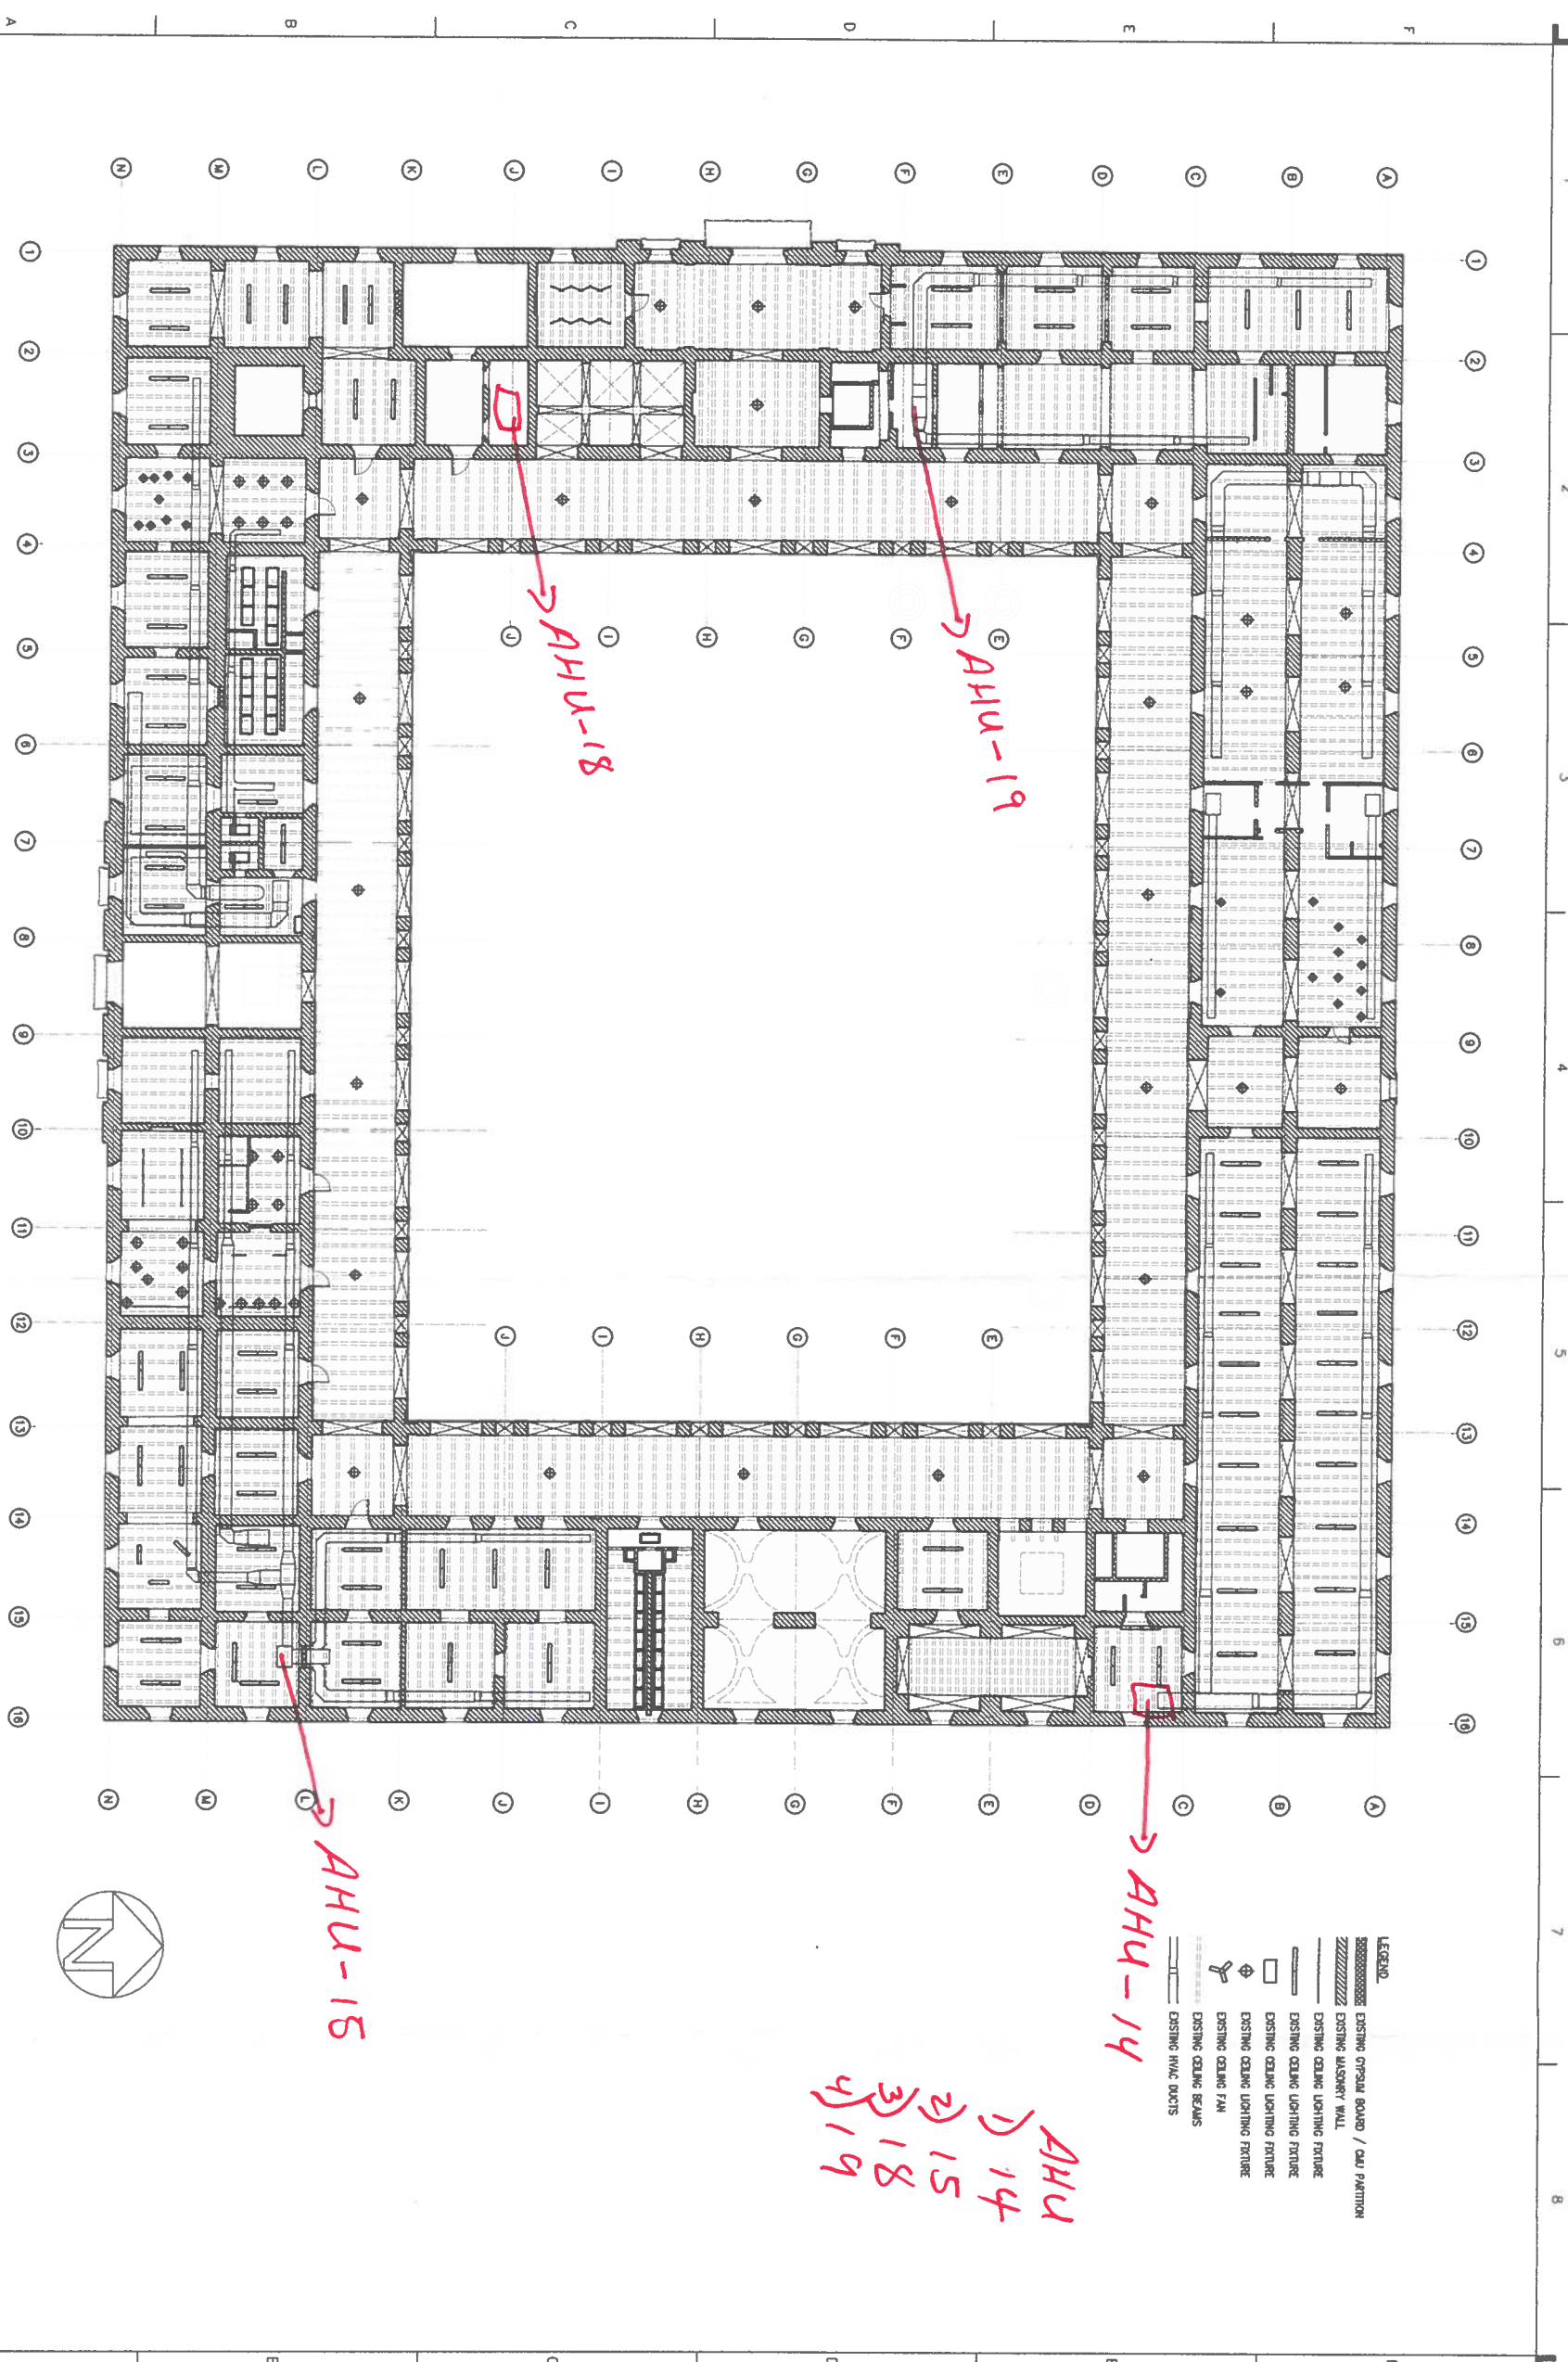

**AS-BUILT GROUND LEVEL REFLECTED CEILING PLAN**  
 SCALE: 1/8"=1'-0"


1 2 3 4 5 6 7 8

A B C D E F G H I J K L M N

1 2 3 4 5 6 7 8 9 10 11 12 13 14 15 16 17 18 19

AHU  
 1) 14  
 2) 15  
 3) 18  
 4) 19



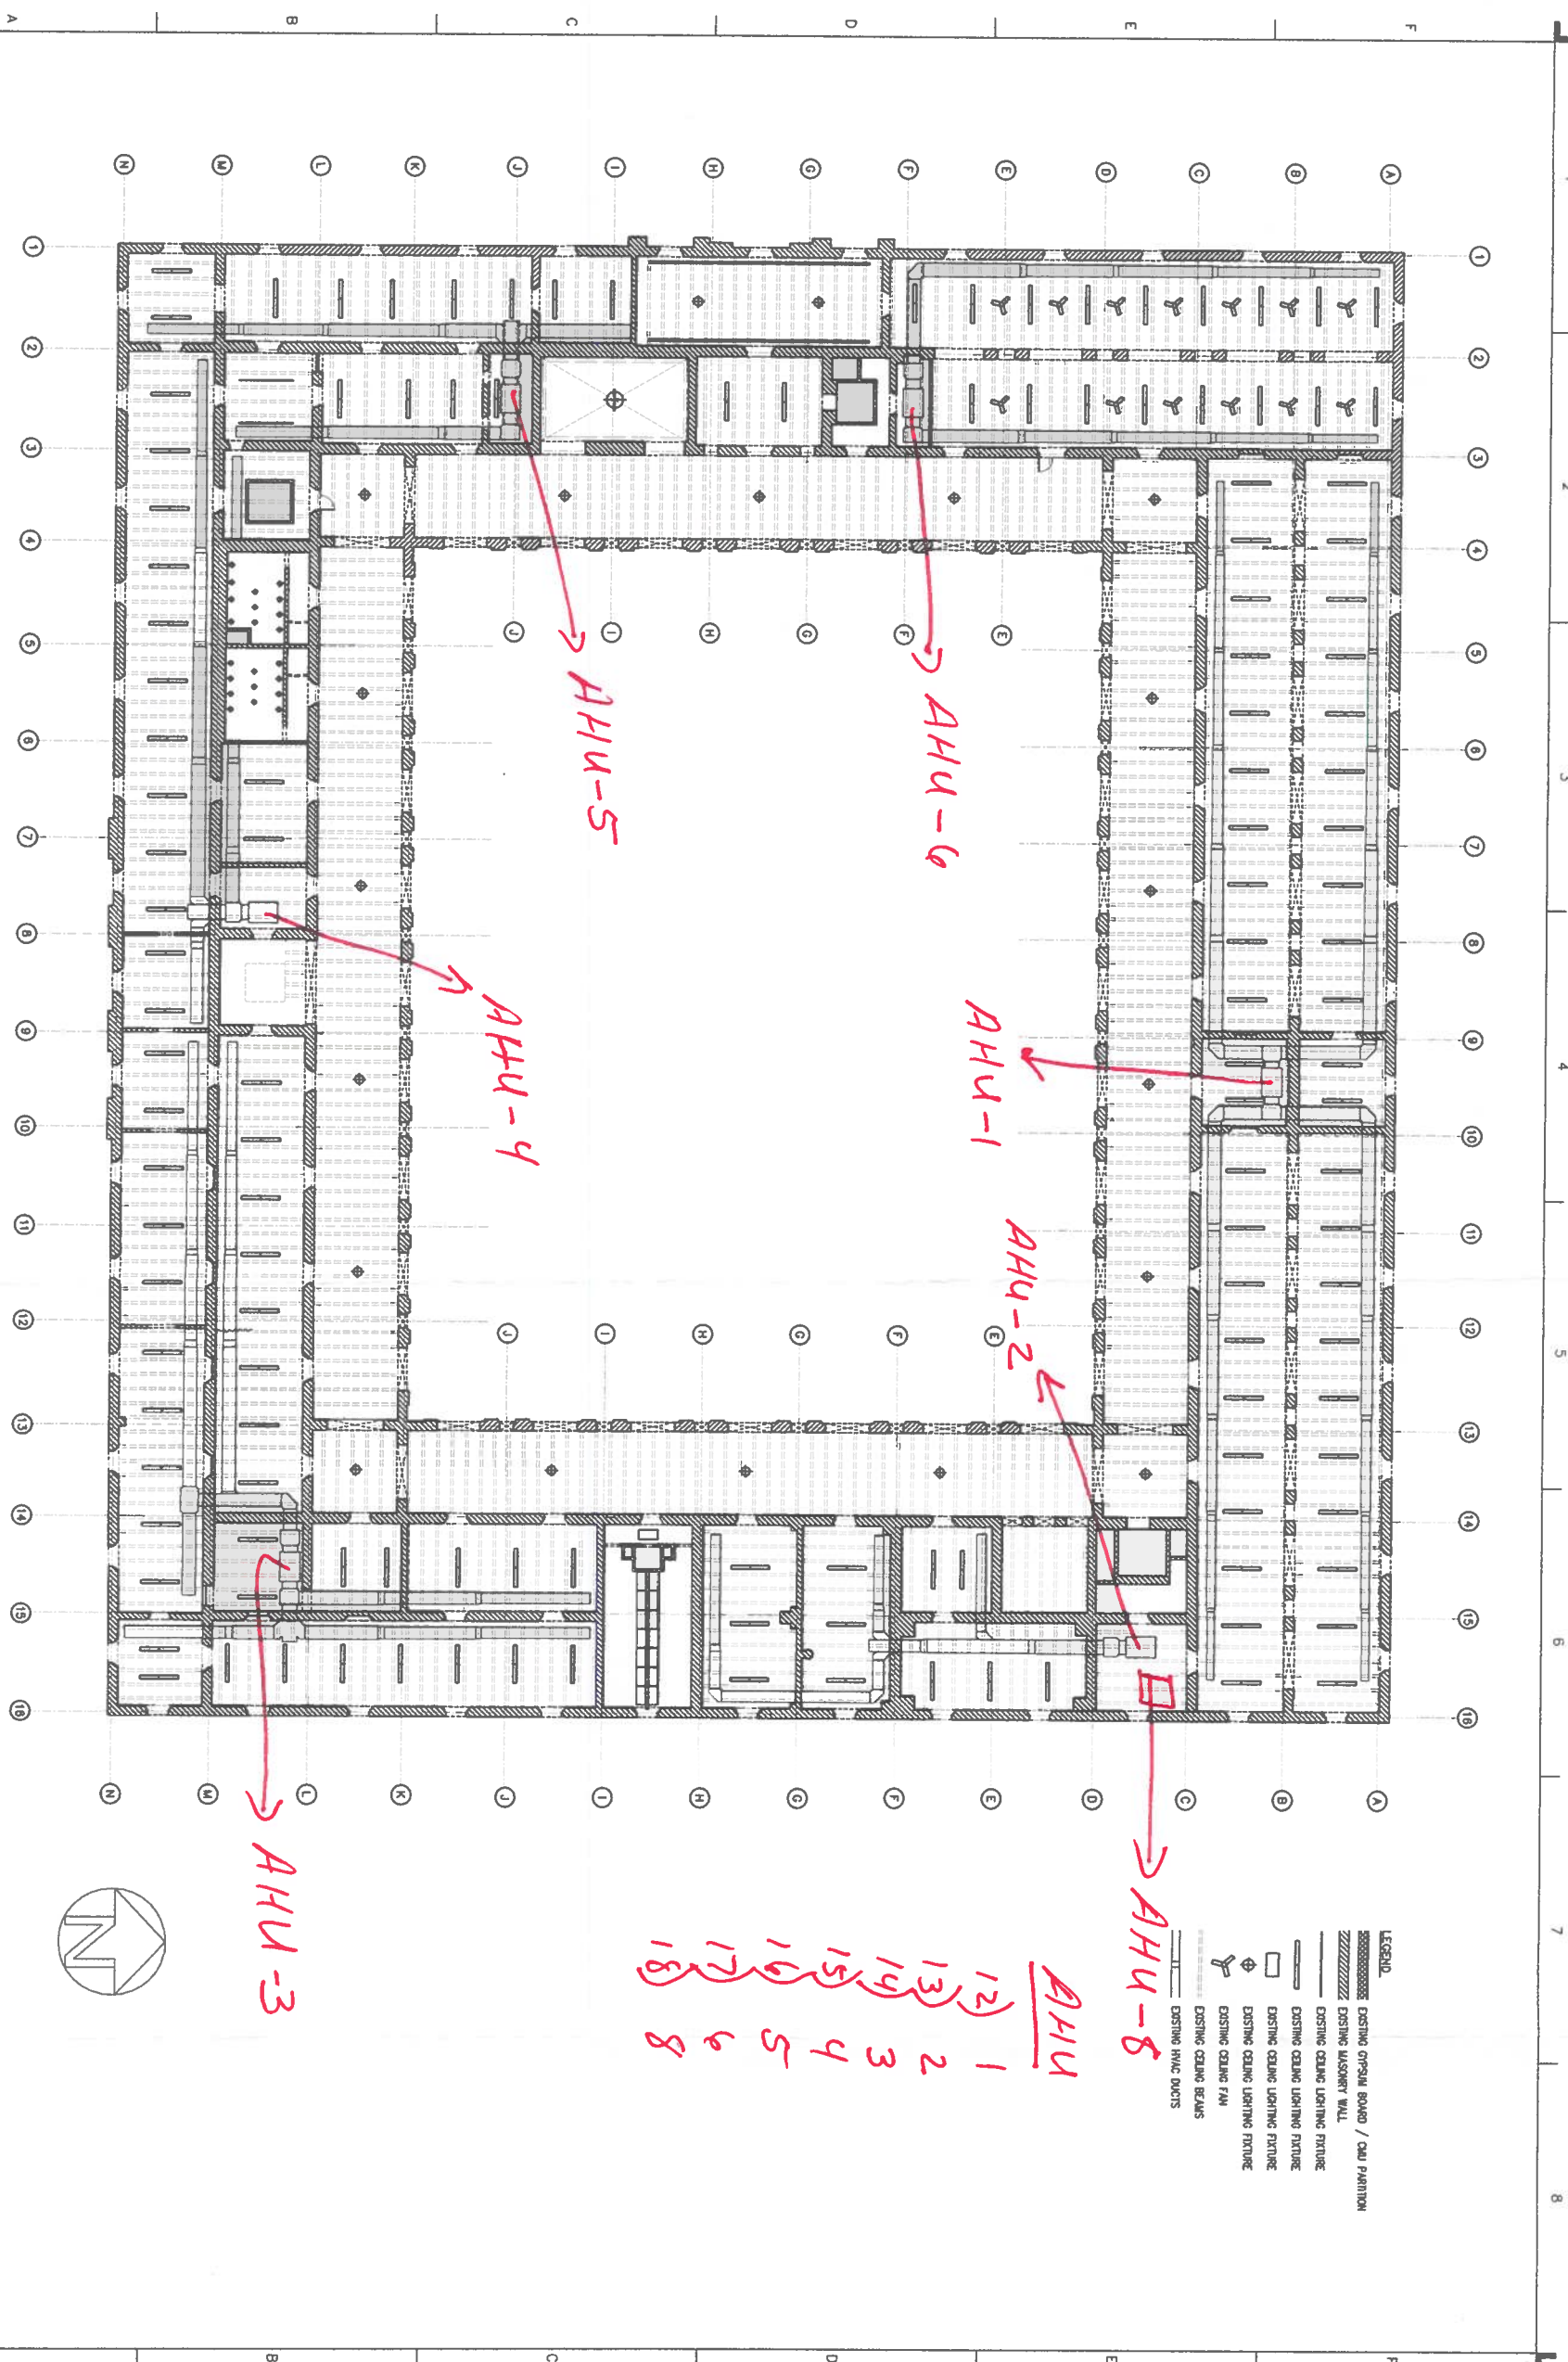

AS-BUILT THIRD LEVEL REFLECTED CEILING PLAN  
SCALE 1/8"=1'-0"

1 2 3 4 5 6 7 8

- LEGEND
- ▬ EXISTING OPSHALE BOARD / CAD PARTITION
  - ▬ EXISTING MASONRY WALL
  - ▬ EXISTING CEILING LIGHTING FIXTURE
  - ▬ EXISTING CEILING LIGHTING FIXTURE
  - ▬ EXISTING CEILING LIGHTING FIXTURE
  - ▬ EXISTING CEILING LIGHTING FIXTURE
  - ▬ EXISTING CEILING LIGHTING FIXTURE
  - ▬ EXISTING CEILING LIGHTING FIXTURE
  - ▬ EXISTING CEILING BEAMS
  - ▬ EXISTING HVAC DUCTS

AHU  
 12  
 13  
 14  
 15  
 16  
 17  
 18  
 1 2 3 4 5 6 8

**MFS CONSULTING, LLC**  
 100 C/O SHELBY ANTHONY DE ANTONIIS  
 SUITE 3 SAN JUAN, PR 00918  
 Phone: 787.331.7413  
 Fax: 787.331.7413  
 www.mfsllc.com

JOSE A. FUERTES  
 PROJ. ENGINEER P.E. LIC. NO. EXP-055-107024  
 18A18

CONSULTANTS

PREPARED FOR:

DRAWING TITLE  
 AS-BUILT THIRD LEVEL REFLECTED CEILING PLAN

PROJECT NAME:  
 ANTIGUO CUARTEL DE BALLAJA RESTORATION PROJECT  
 (FEA/ANALYSIS SP-0-45 PROJECT)  
 AS-BUILT DRAWINGS  
 SCALE: UNZAGUON, EQUINA BARRERENA, SAN JUAN, PUERTO RICO, 00901

NO.	ISSUE	DATE

PROJECT NO.: 1820029  
 DATE: 04/JUNE/22  
 SCALE: AS NOTED  
 DRAWN BY: JRS/BBM  
 CHECKED BY: \_\_\_\_\_

DRAWING NUMBER  
 AB-8  
 SHEET 9 OF 13